


RAY OWEN OVAL REDEVELOPMENT


96 GLADYS ROAD, LESMURDIE, WA.

DRAWING SCHEDULE:

SE_11694_F000	COVER SHEET AND DRAWING SCHEDULE
SE_11694_F010	GENERAL NOTES AND LEGEND
SE_11694_F100	SITE CLEARING LAYOUT PLAN
SE_11694_F150	BULK EARTHWORKS LAYOUT PLAN
SE_11694_F200	GENERAL ARRANGEMENT LAYOUT PLAN
SE_11694_F250	SITE SECTIONS - SHEET 1 OF 2
SE_11694_F251	SITE SECTIONS - SHEET 2 OF 2
SE_11694_F300	STORMWATER DRAINAGE LAYOUT PLAN
SE_11694_F320	STORMWATER DRAINAGE DETAILS AND PIT SCHEDULE
SE_11694_F350	STORMWATER DRAINAGE LONG SECTIONS - SHEET 1 OF 3
SE_11694_F351	STORMWATER DRAINAGE LONG SECTIONS - SHEET 2 OF 3
SE_11694_F351	STORMWATER DRAINAGE LONG SECTIONS - SHEET 3 OF 3
SE_11694_F500	IRRIGATION LAYOUT PLAN
SE_11694_F525	IRRIGATION NOTES LEGEND AND SCHEDULE
SE_11694_F550	IRRIGATION DETAILS
SE_11694_F650	PAVEMENT PROFILES AND DETAILS
SE_11694_F700	1.05m HIGH FENCE DETAILS
SE_11694_F701	4.0m HIGH FENCE DETAILS
SE_11694_F702	6.0m HIGH BEHIND GOAL NETTING DETAILS

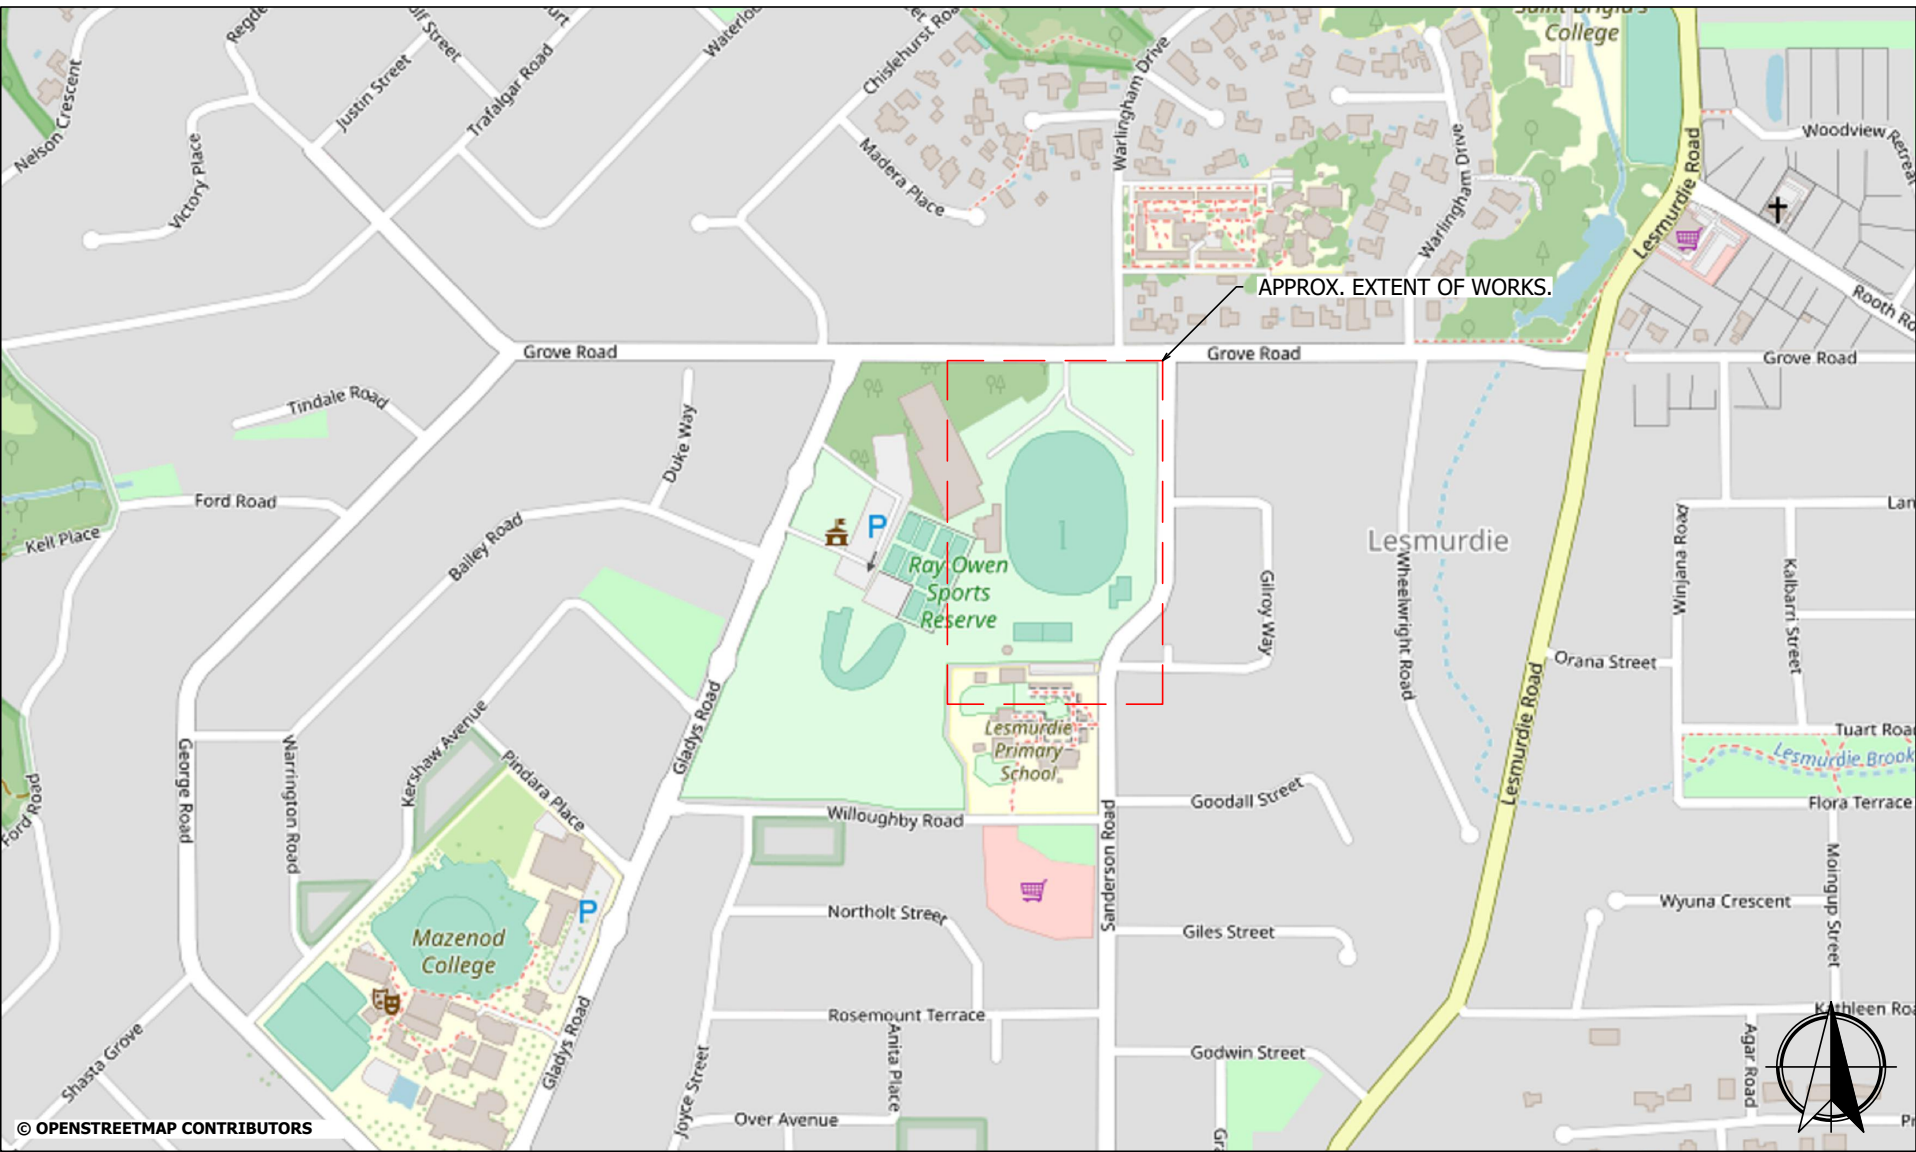

LOCALITY PLAN - 96 GLADYS ROAD, LESMURDIE, WA, 6076.

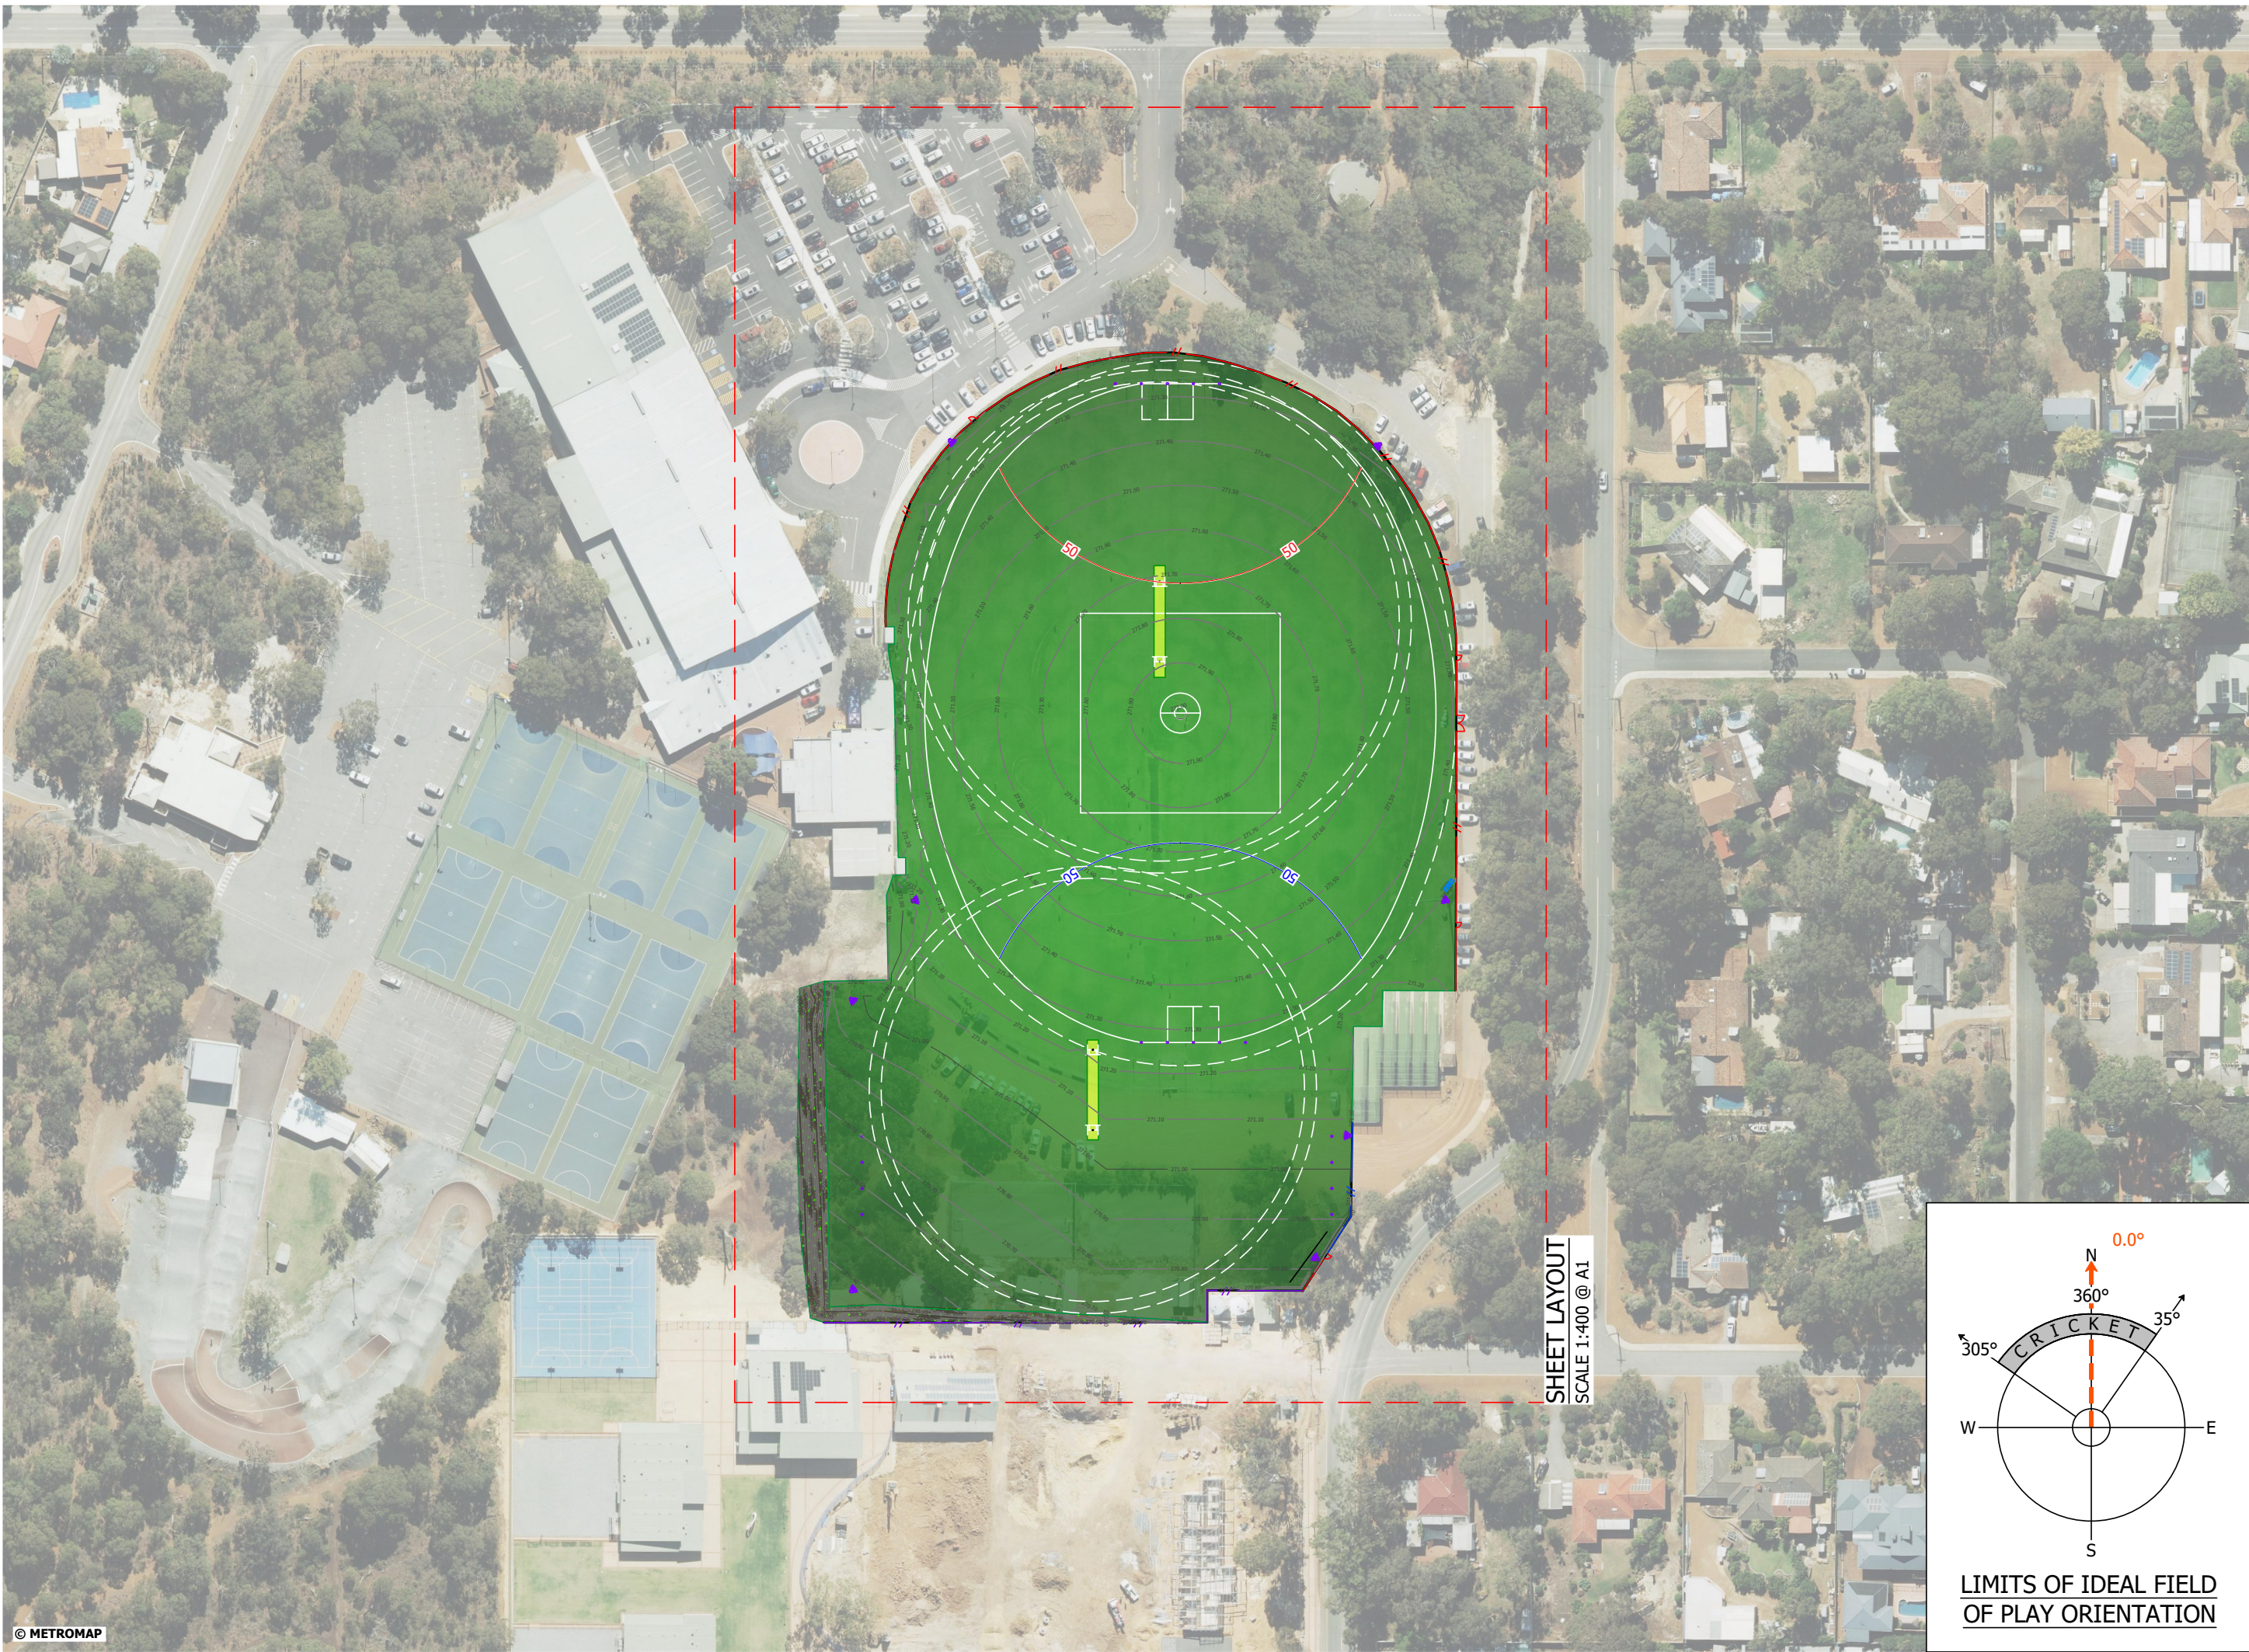

OVERALL SITE LAYOUT PLAN
ALL AERIAL IMAGERY USED IN THE PRODUCTION OF THIS DRAWING SET HAVE BEEN UNDER LICENSE FROM METROMAP.

NOT FOR CONSTRUCTION



SPORTENG™

P3	05/04/24	RKC	BGC	JDH	PRELIMINARY ISSUE
P2	31/01/24	RKC	BGC	JDH	PRELIMINARY ISSUE
P1	13/12/23	RKC	BGC	JDH	PRELIMINARY ISSUE
Issue	Date	By	Chkd	Appd	Description


Job Title
RAY OWEN OVAL
REDEVELOPMENT

Drawing Title
COVER SHEET
AND DRAWING SCHEDULE

Discipline
FIELD OF PLAY
Drawing Status
PRELIMINARY
Drawing Number
SE_11694_F000


Issue
P3

© SPORTENG

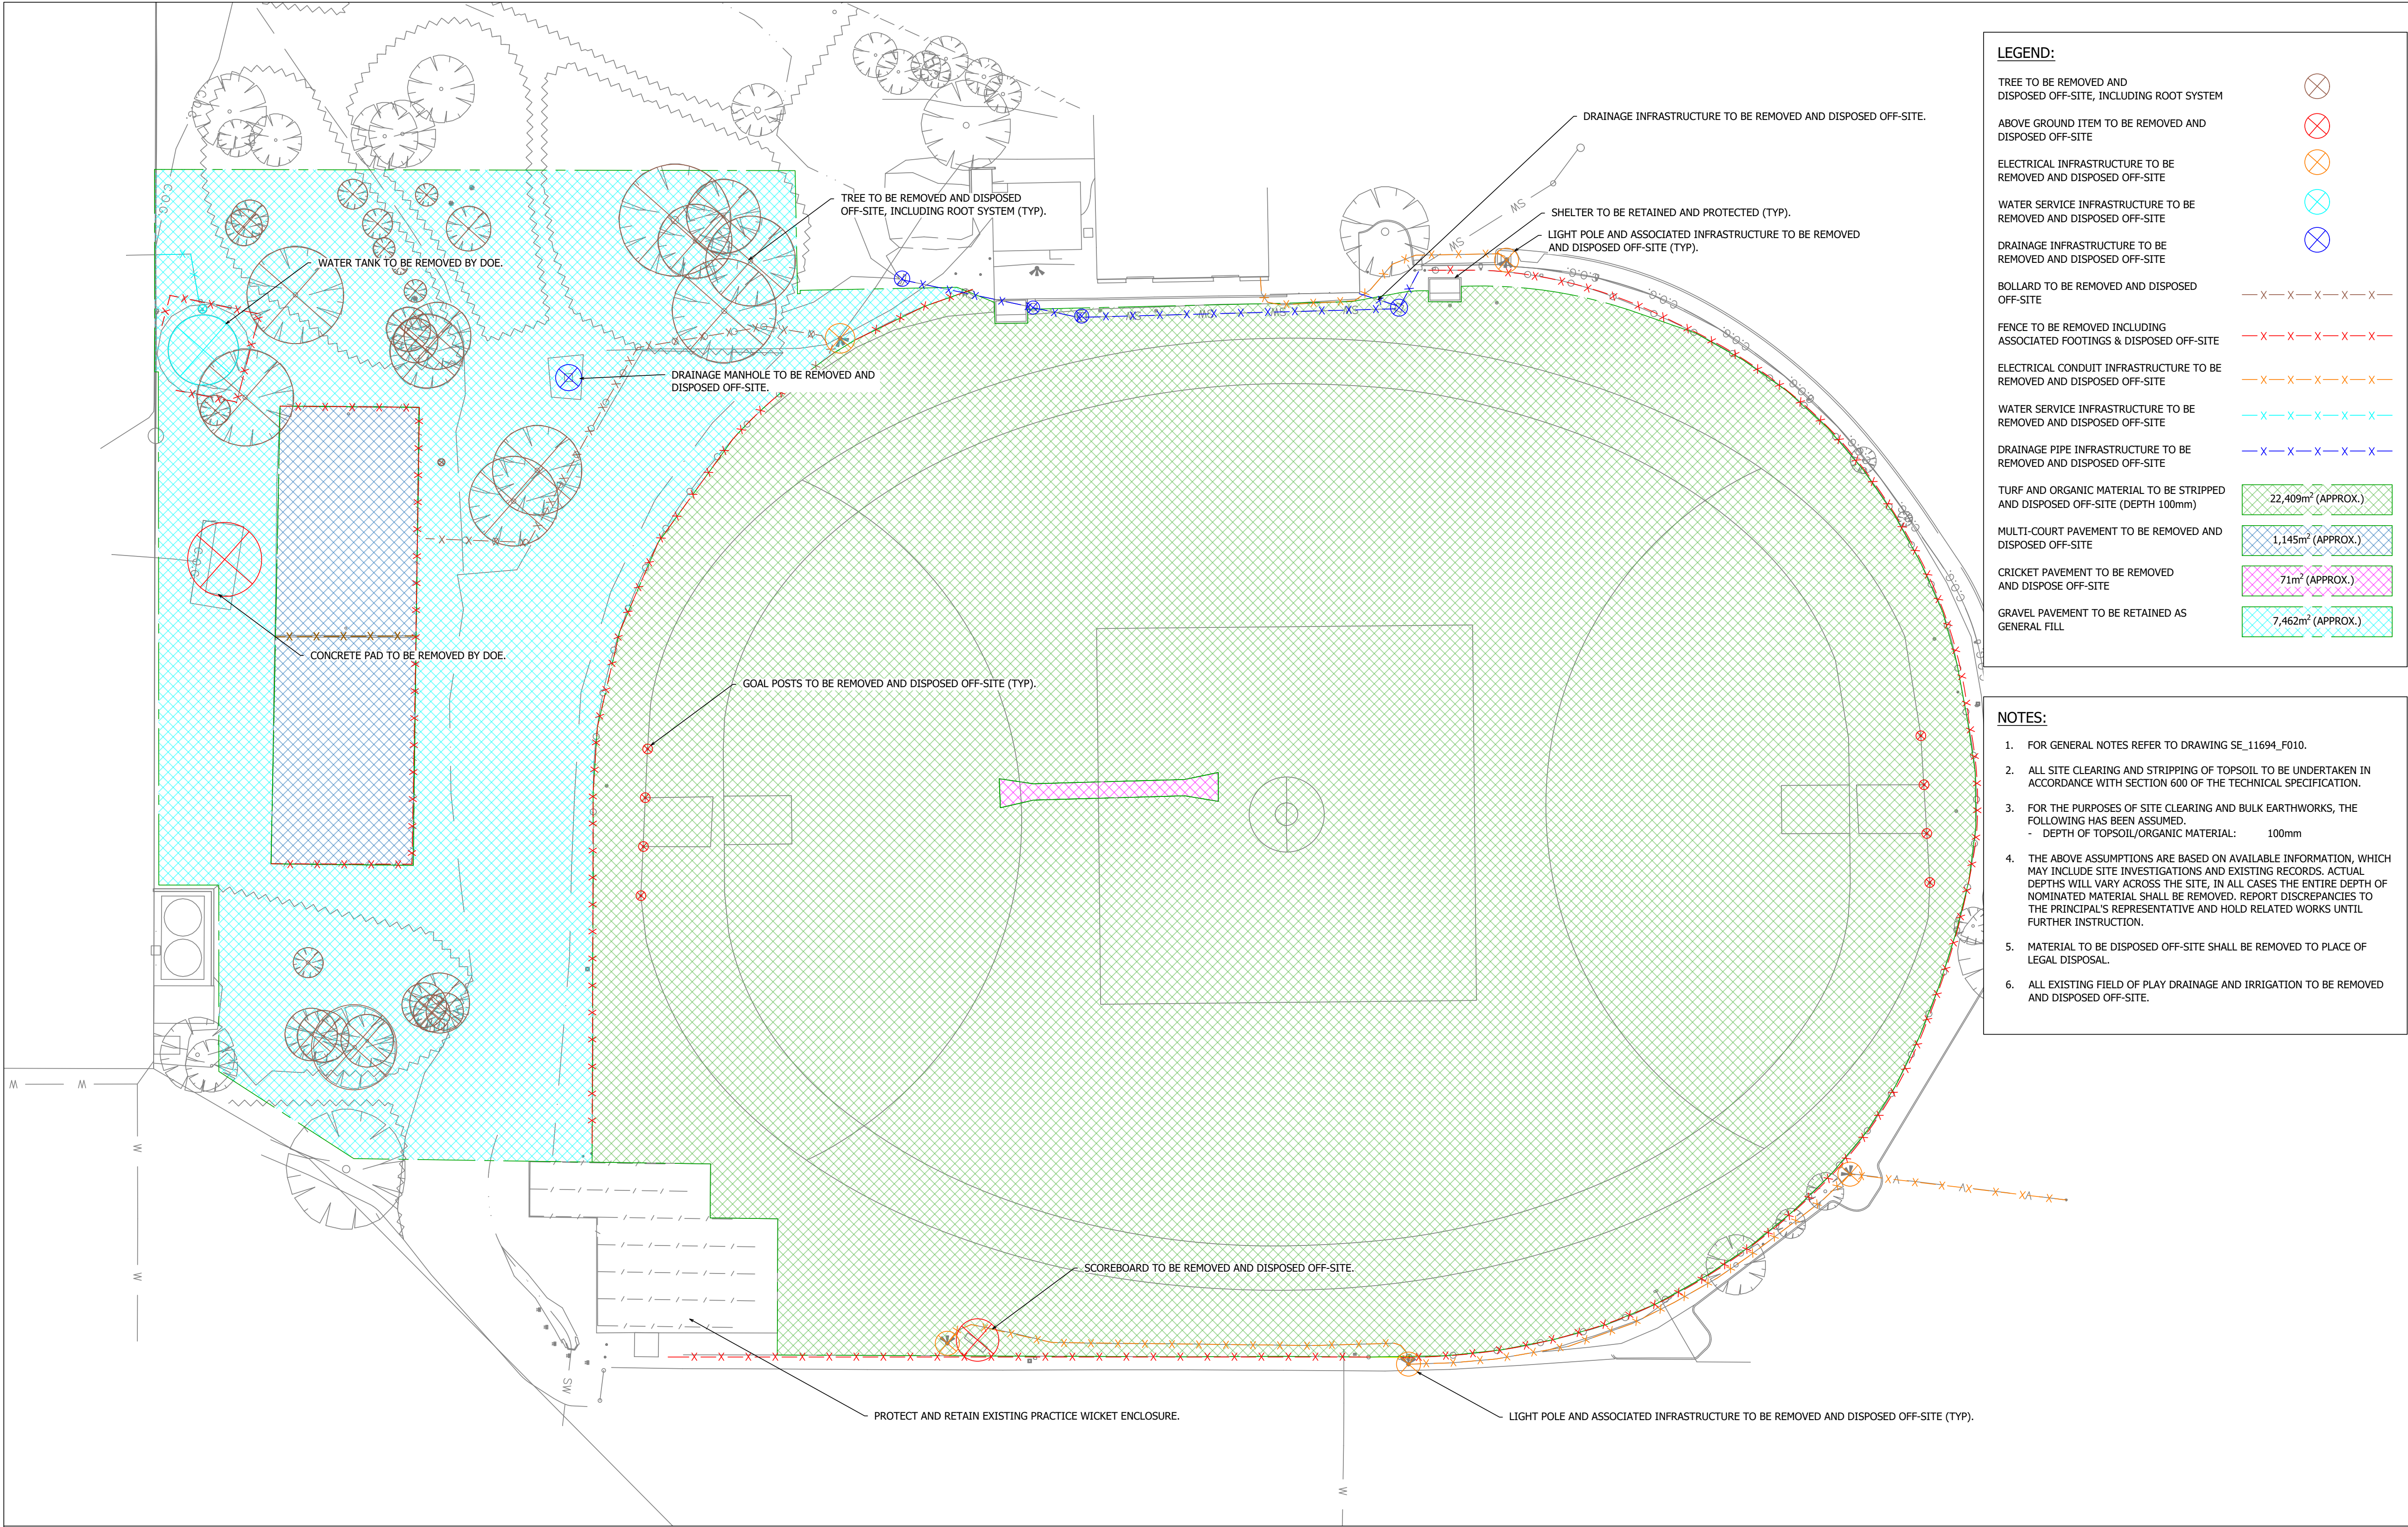

WARNING
BEWARE OF UNDERGROUND SERVICES
THE LOCATION OF UNDERGROUND SERVICES ARE APPROXIMATE ONLY. IT IS THE RESPONSIBILITY OF THE CONTRACTOR TO PROVE THEIR EXACT POSITION ON SITE. NO GUARANTEE IS GIVEN THAT ALL EXISTING SERVICES ARE SHOWN.

NOT FOR CONSTRUCTION

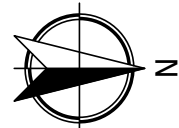


P3	05/04/24	RKC	BGC	JDH	PRELIMINARY ISSUE
P2	31/01/24	RKC	BGC	JDH	PRELIMINARY ISSUE
P1	13/12/23	RKC	BGC	JDH	PRELIMINARY ISSUE
Issue	Date	By	Chkd	Appd	Description

Job Title
RAY OWEN OVAL
REDEVELOPMENT


Drawing Title
SITE CLEARING
LAYOUT PLAN

0	5m	10m	15m	20m	25m
SCALE 1:400 @ A1					
Discipline					
FIELD OF PLAY					
Drawing Status					
PRELIMINARY					
Drawing Number					
SE_11694_F100					
Issue					
P3					

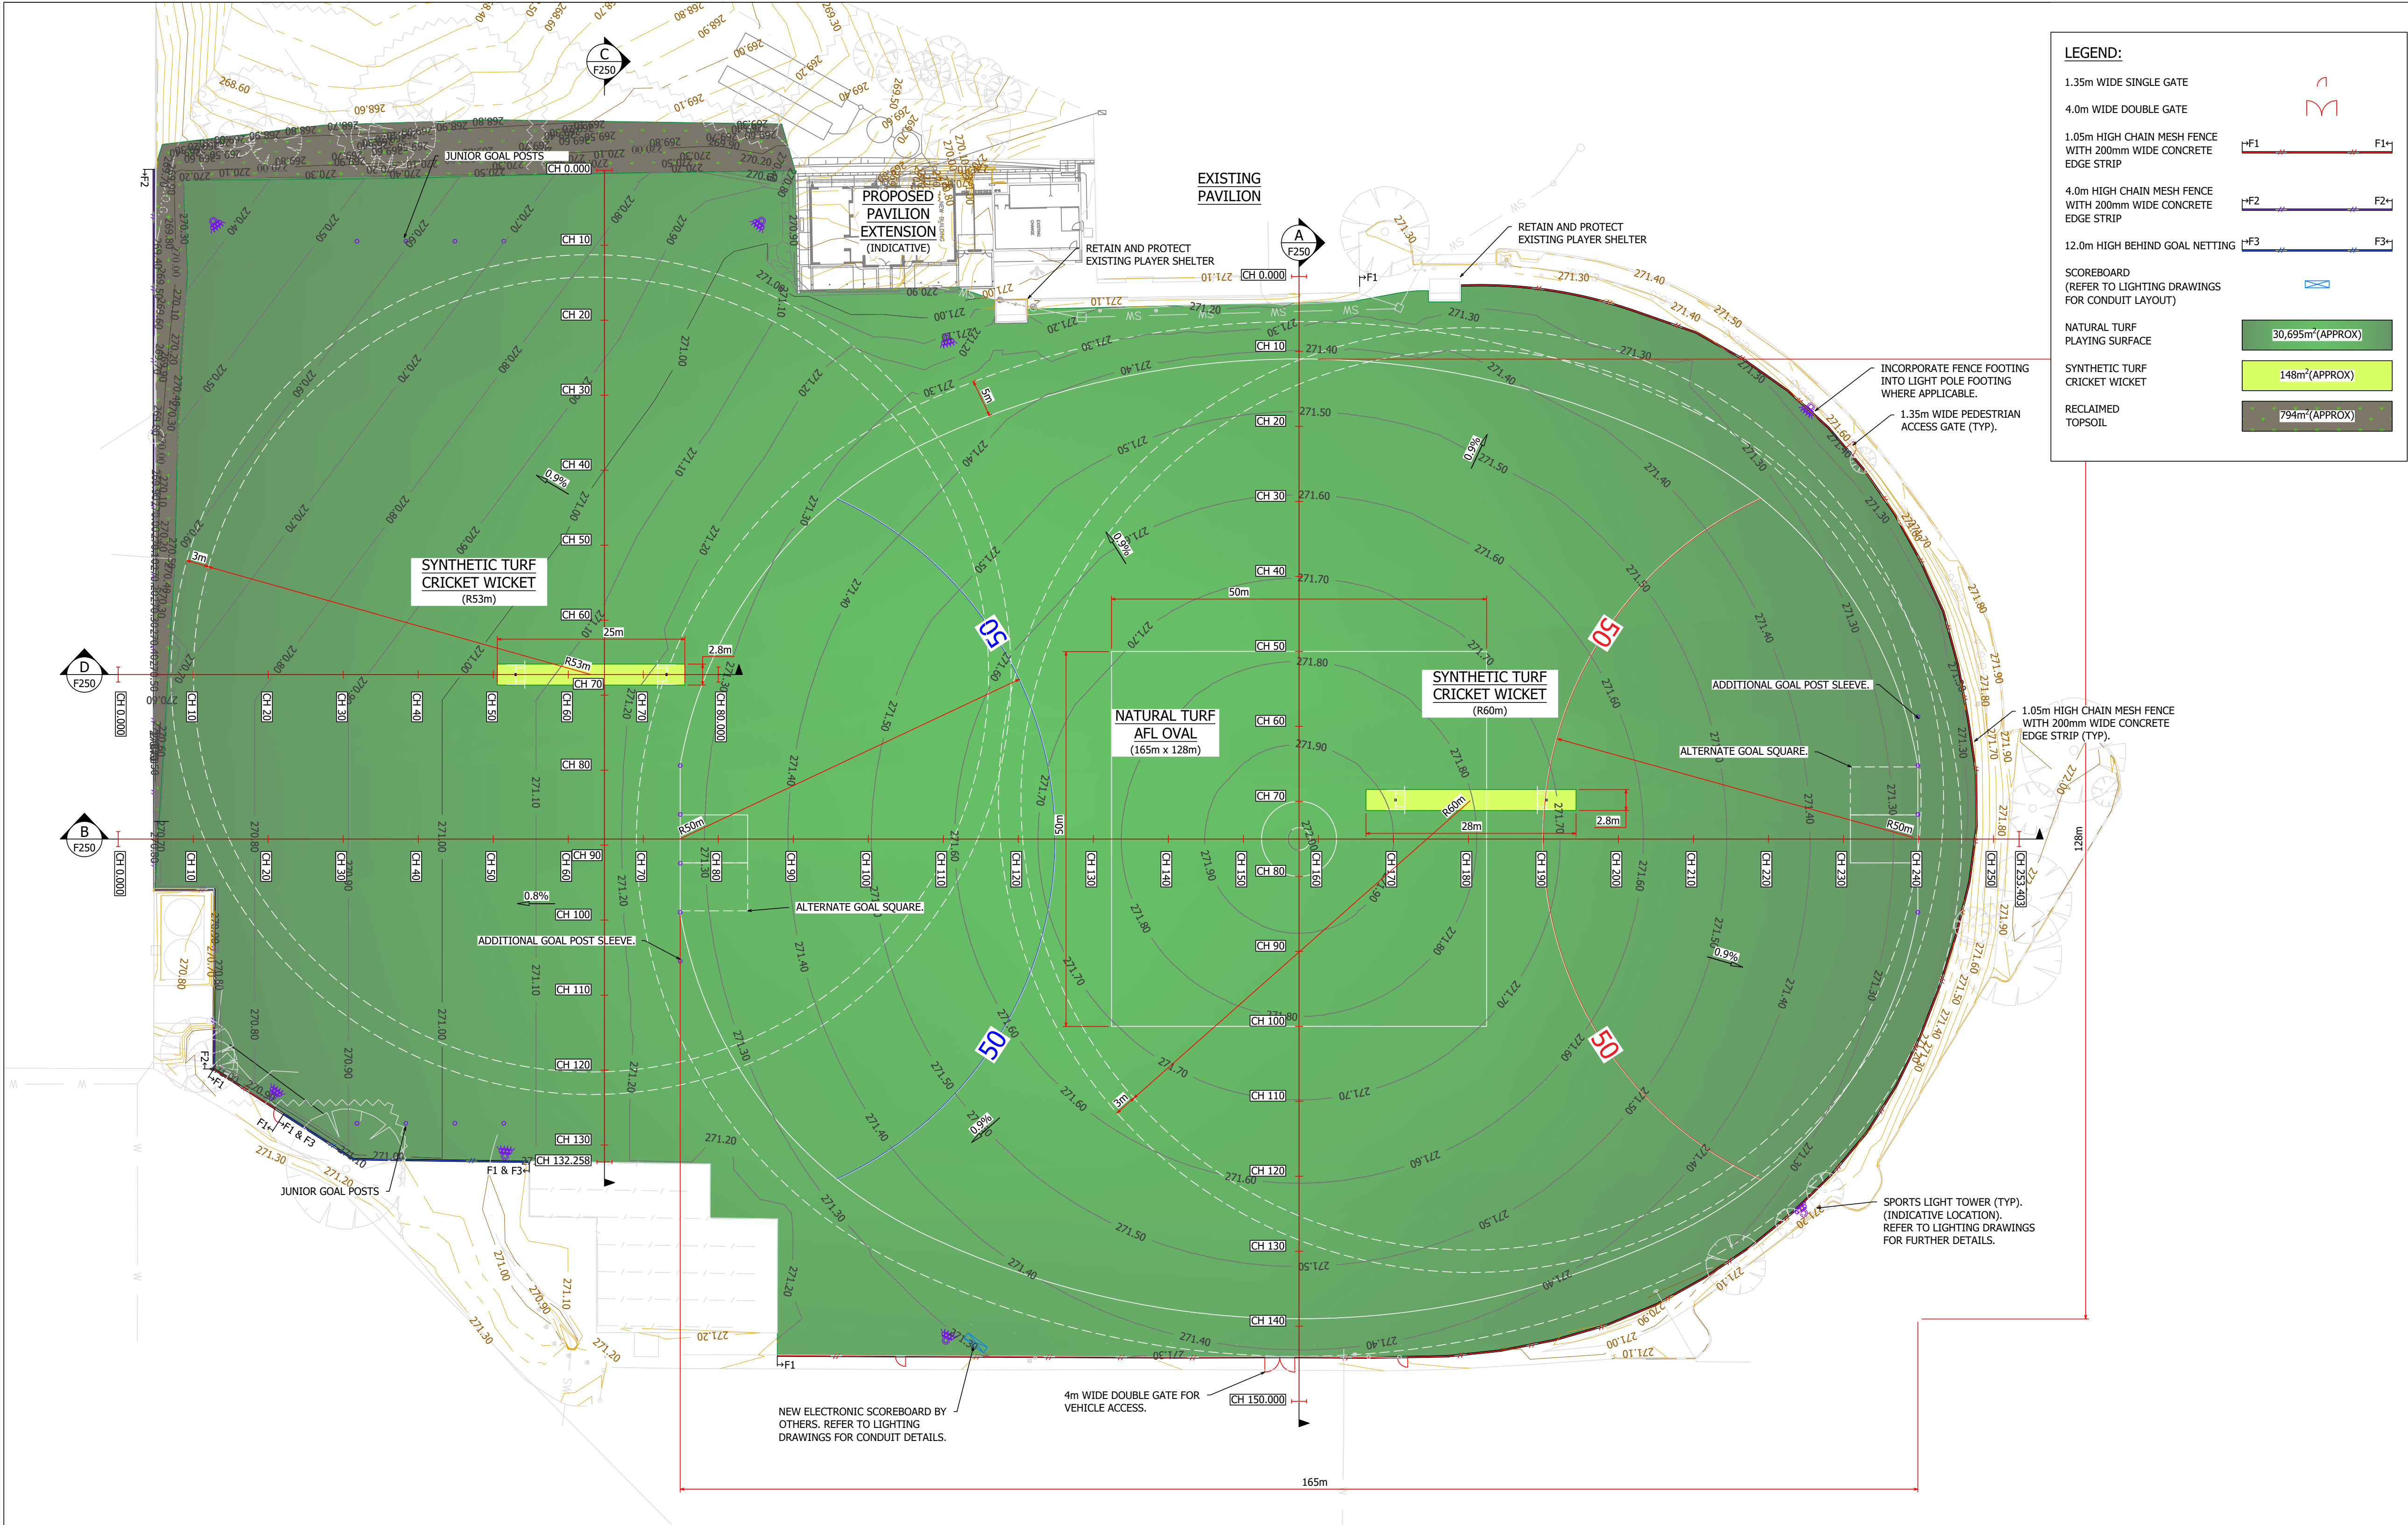

WARNING
BEWARE OF UNDERGROUND SERVICES
THE LOCATION OF UNDERGROUND SERVICES ARE APPROXIMATE ONLY. IT IS THE RESPONSIBILITY OF THE CONTRACTOR TO PROVE THEIR EXACT POSITION ON SITE. NO GUARANTEE IS GIVEN THAT ALL EXISTING SERVICES ARE SHOWN.

NOT FOR CONSTRUCTION

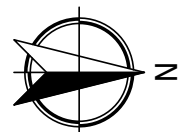


P3	05/04/24	RKC	BGC	JDH	PRELIMINARY ISSUE
P2	31/01/24	RKC	BGC	JDH	PRELIMINARY ISSUE
P1	13/12/23	RKC	BGC	JDH	PRELIMINARY ISSUE
Issue	Date	By	Chkd	Appd	Description

Job Title
RAY OWEN OVAL
REDEVELOPMENT


Drawing Title
GENERAL ARRANGEMENT
LAYOUT PLAN

0	5m	10m	15m	20m	25m
SCALE 1:400 @ A1					
Discipline					
FIELD OF PLAY					
Drawing Status					
PRELIMINARY					
Drawing Number					
SE_11694_F200					
Issue					
P3					

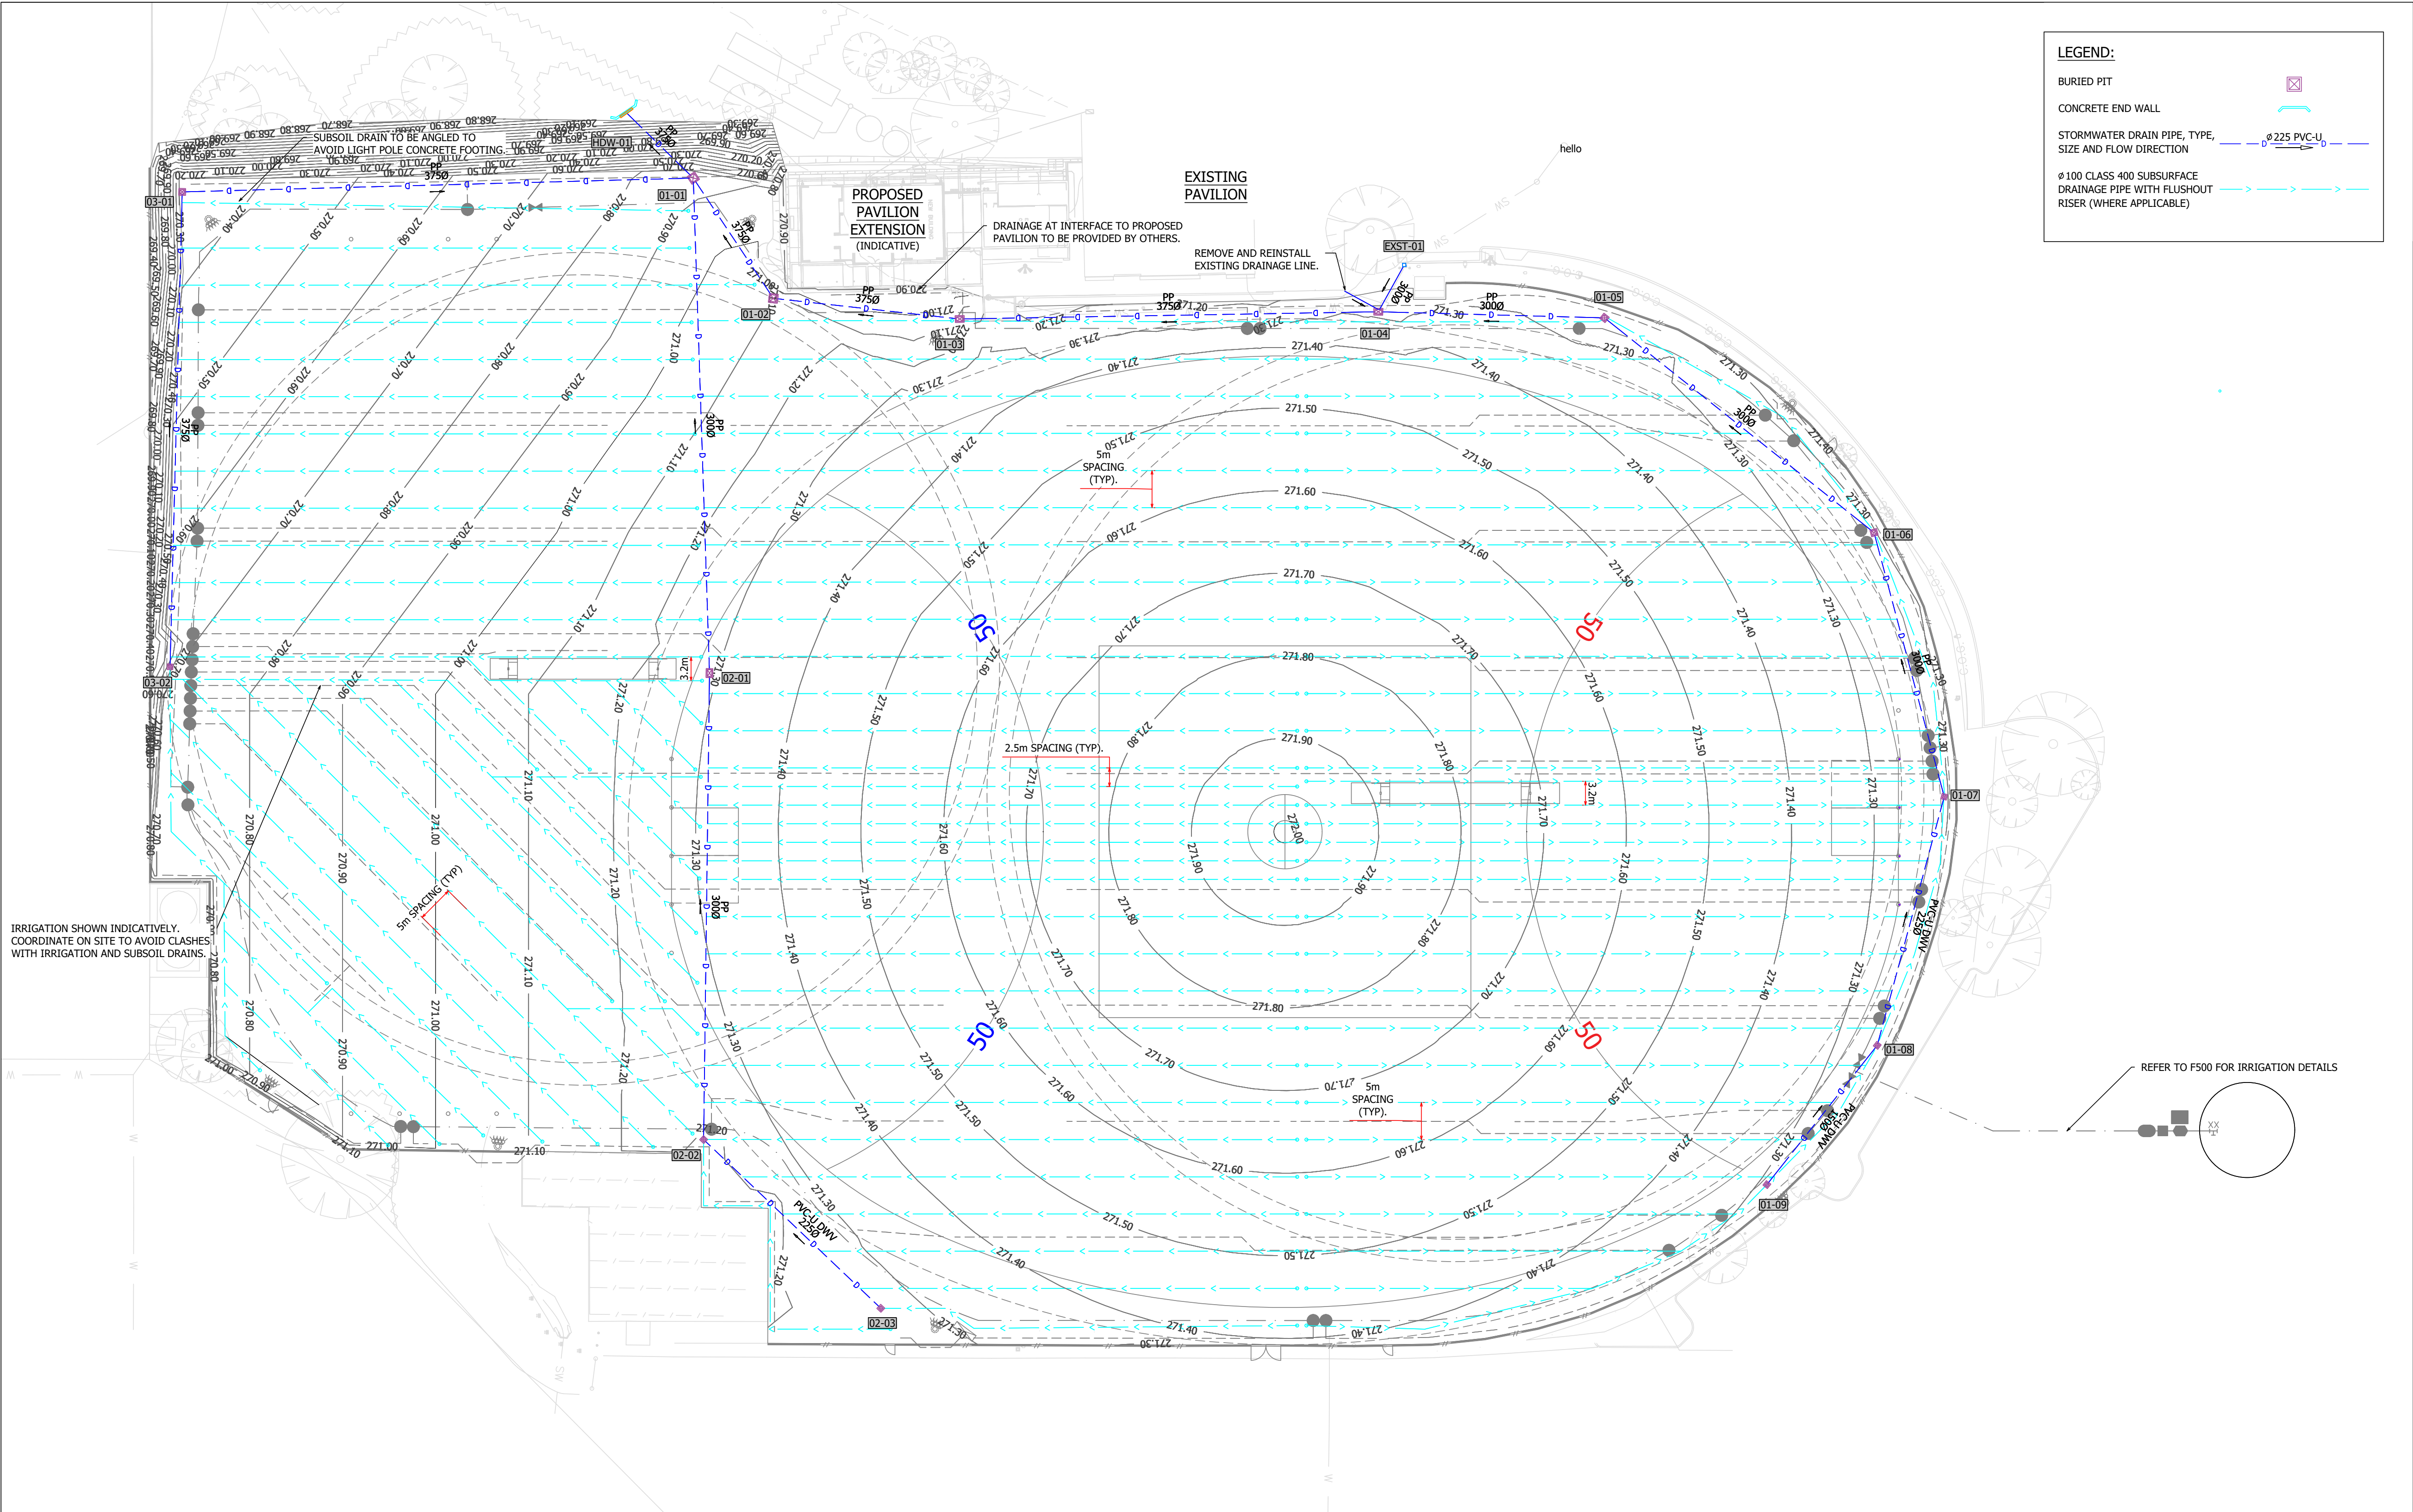

WARNING
BEWARE OF UNDERGROUND SERVICES
THE LOCATION OF UNDERGROUND SERVICES ARE APPROXIMATE ONLY. IT IS THE RESPONSIBILITY OF THE CONTRACTOR TO PROVE THEIR EXACT POSITION ON SITE. NO GUARANTEE IS GIVEN THAT ALL EXISTING SERVICES ARE SHOWN.

NOT FOR CONSTRUCTION

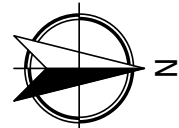



P3	05/04/24	RKC	BGC	JDH	PRELIMINARY ISSUE
P2	31/01/24	RKC	BGC	JDH	PRELIMINARY ISSUE
P1	13/12/23	RKC	BGC	JDH	PRELIMINARY ISSUE
Issue	Date	By	Chkd	Appd	Description

Job Title
RAY OWEN OVAL
REDEVELOPMENT

Drawing Title
STORMWATER DRAINAGE
LAYOUT PLAN

0	5m	10m	15m	20m	25m
SCALE 1:400 @ A1					
Discipline					
FIELD OF PLAY					
Drawing Status					
PRELIMINARY					
Drawing Number					
SE_11694_F300					
					Issue
					P3

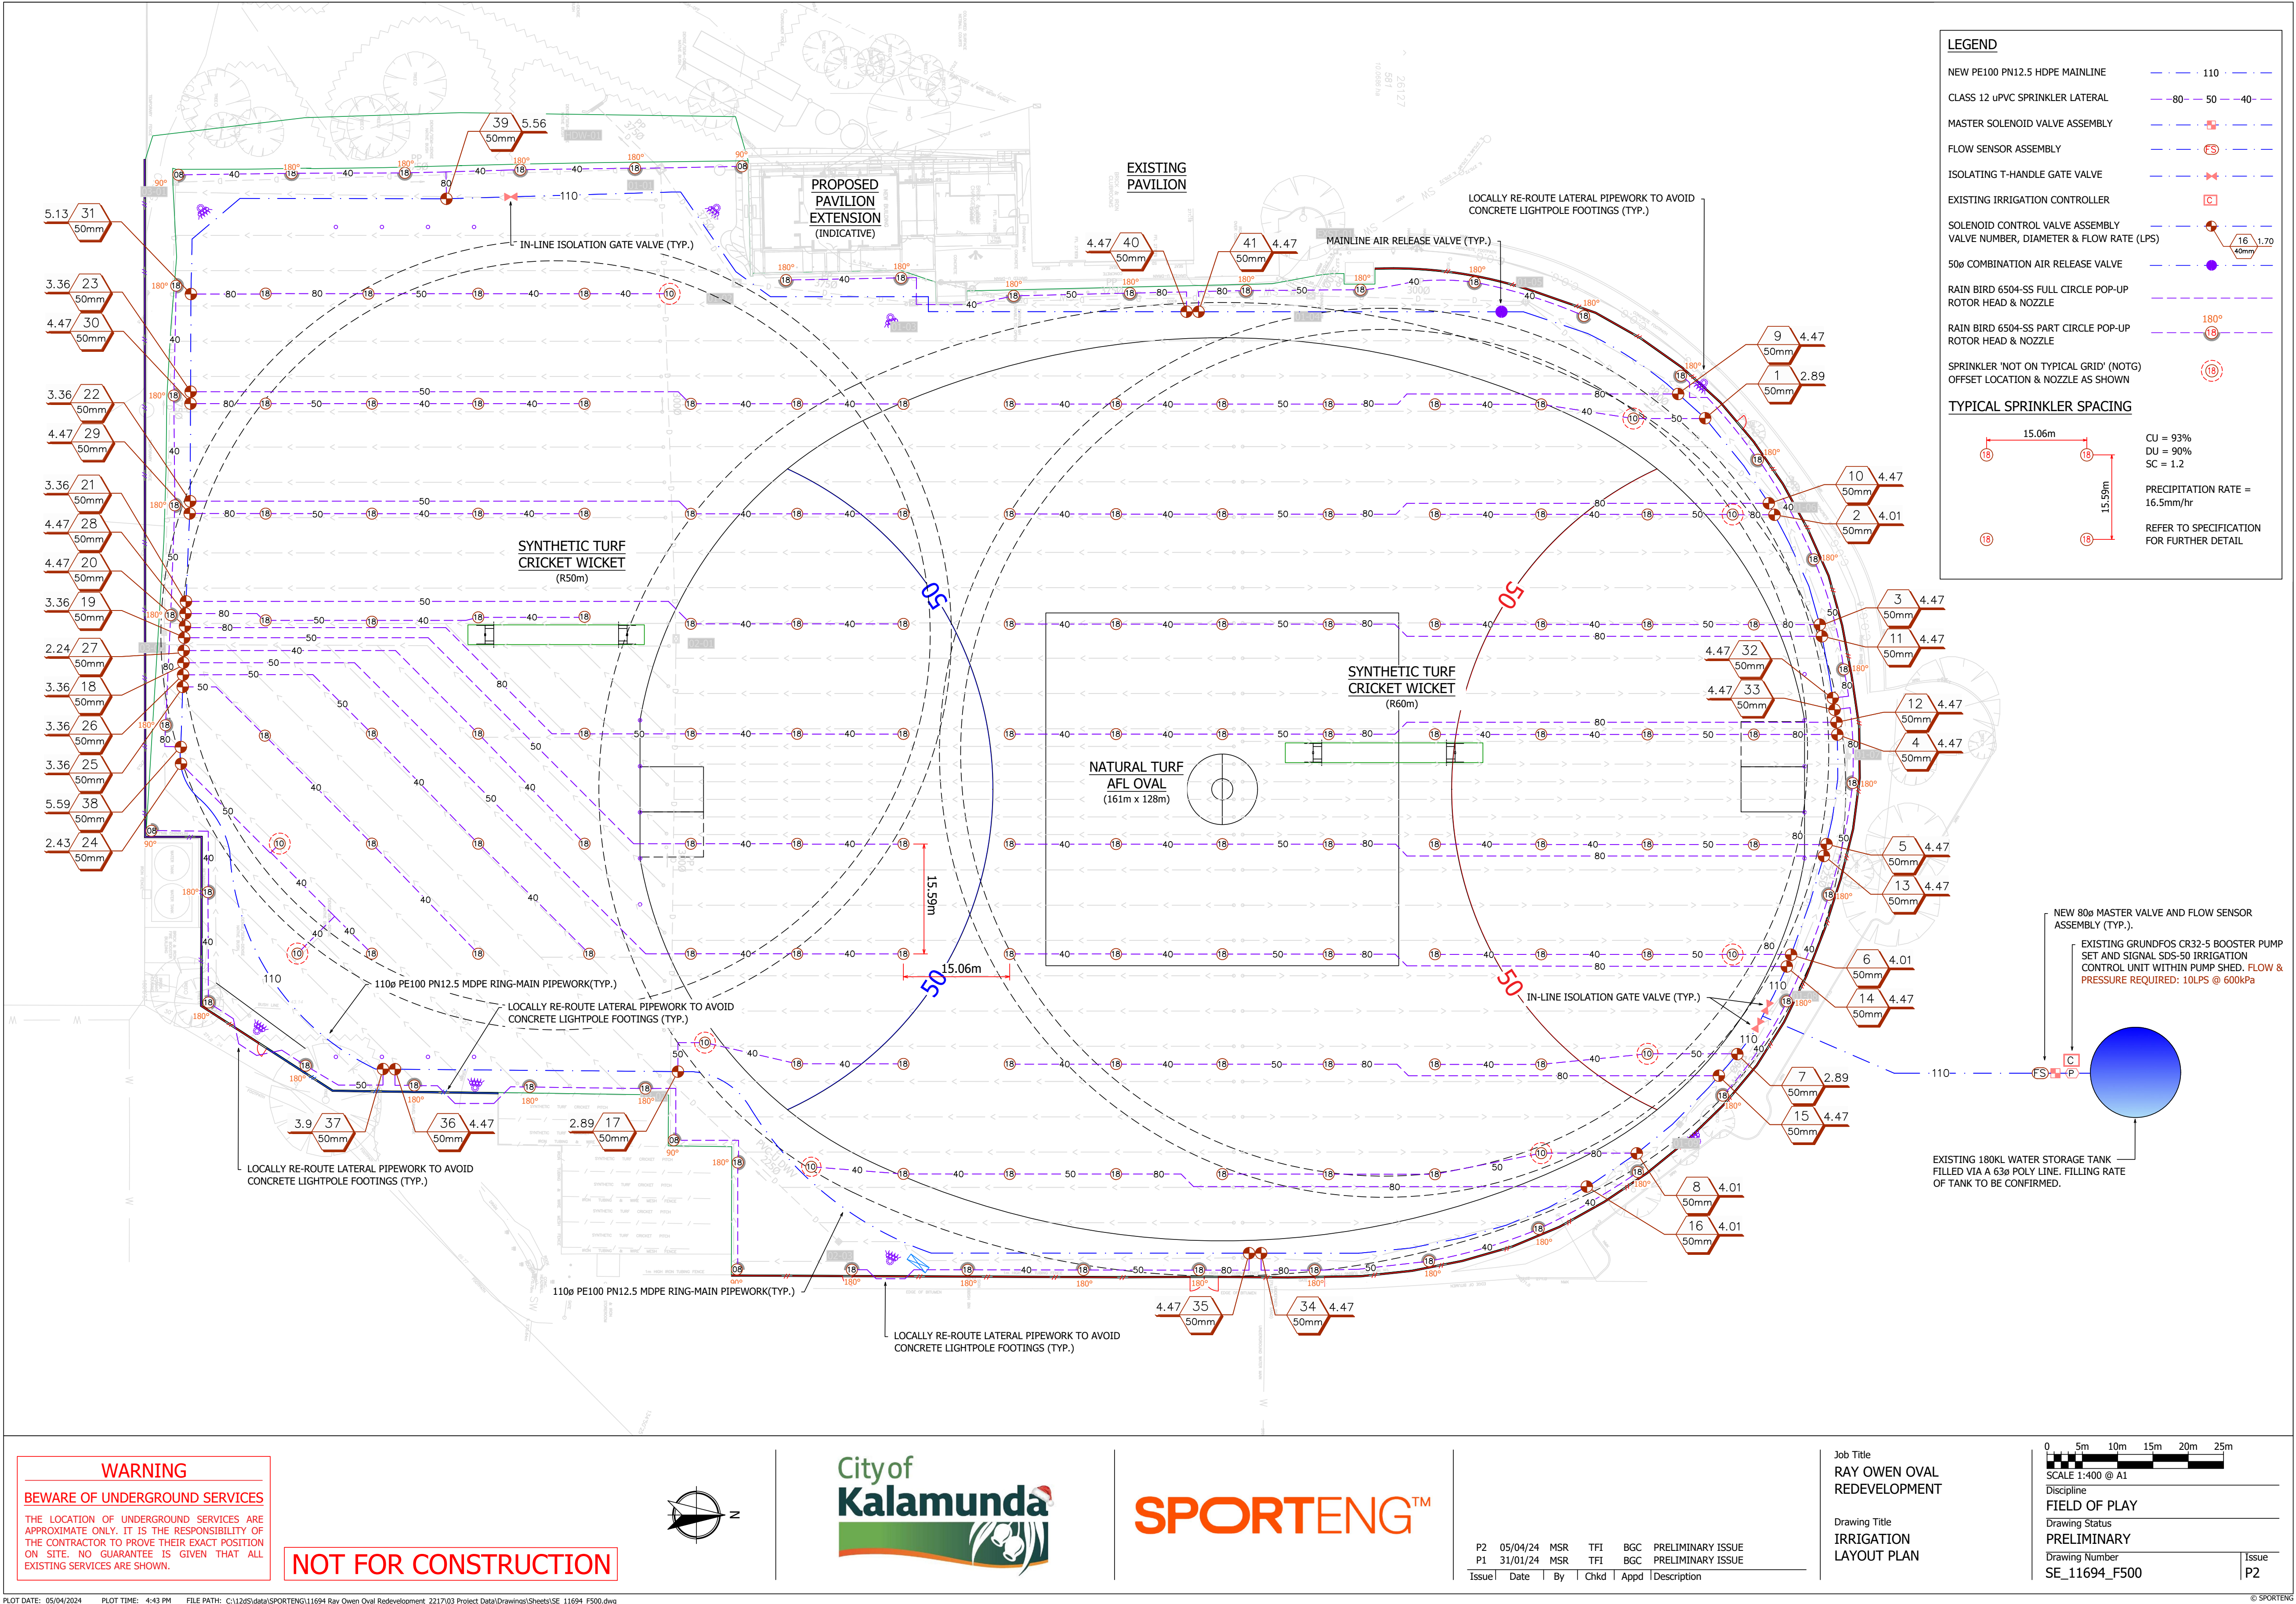

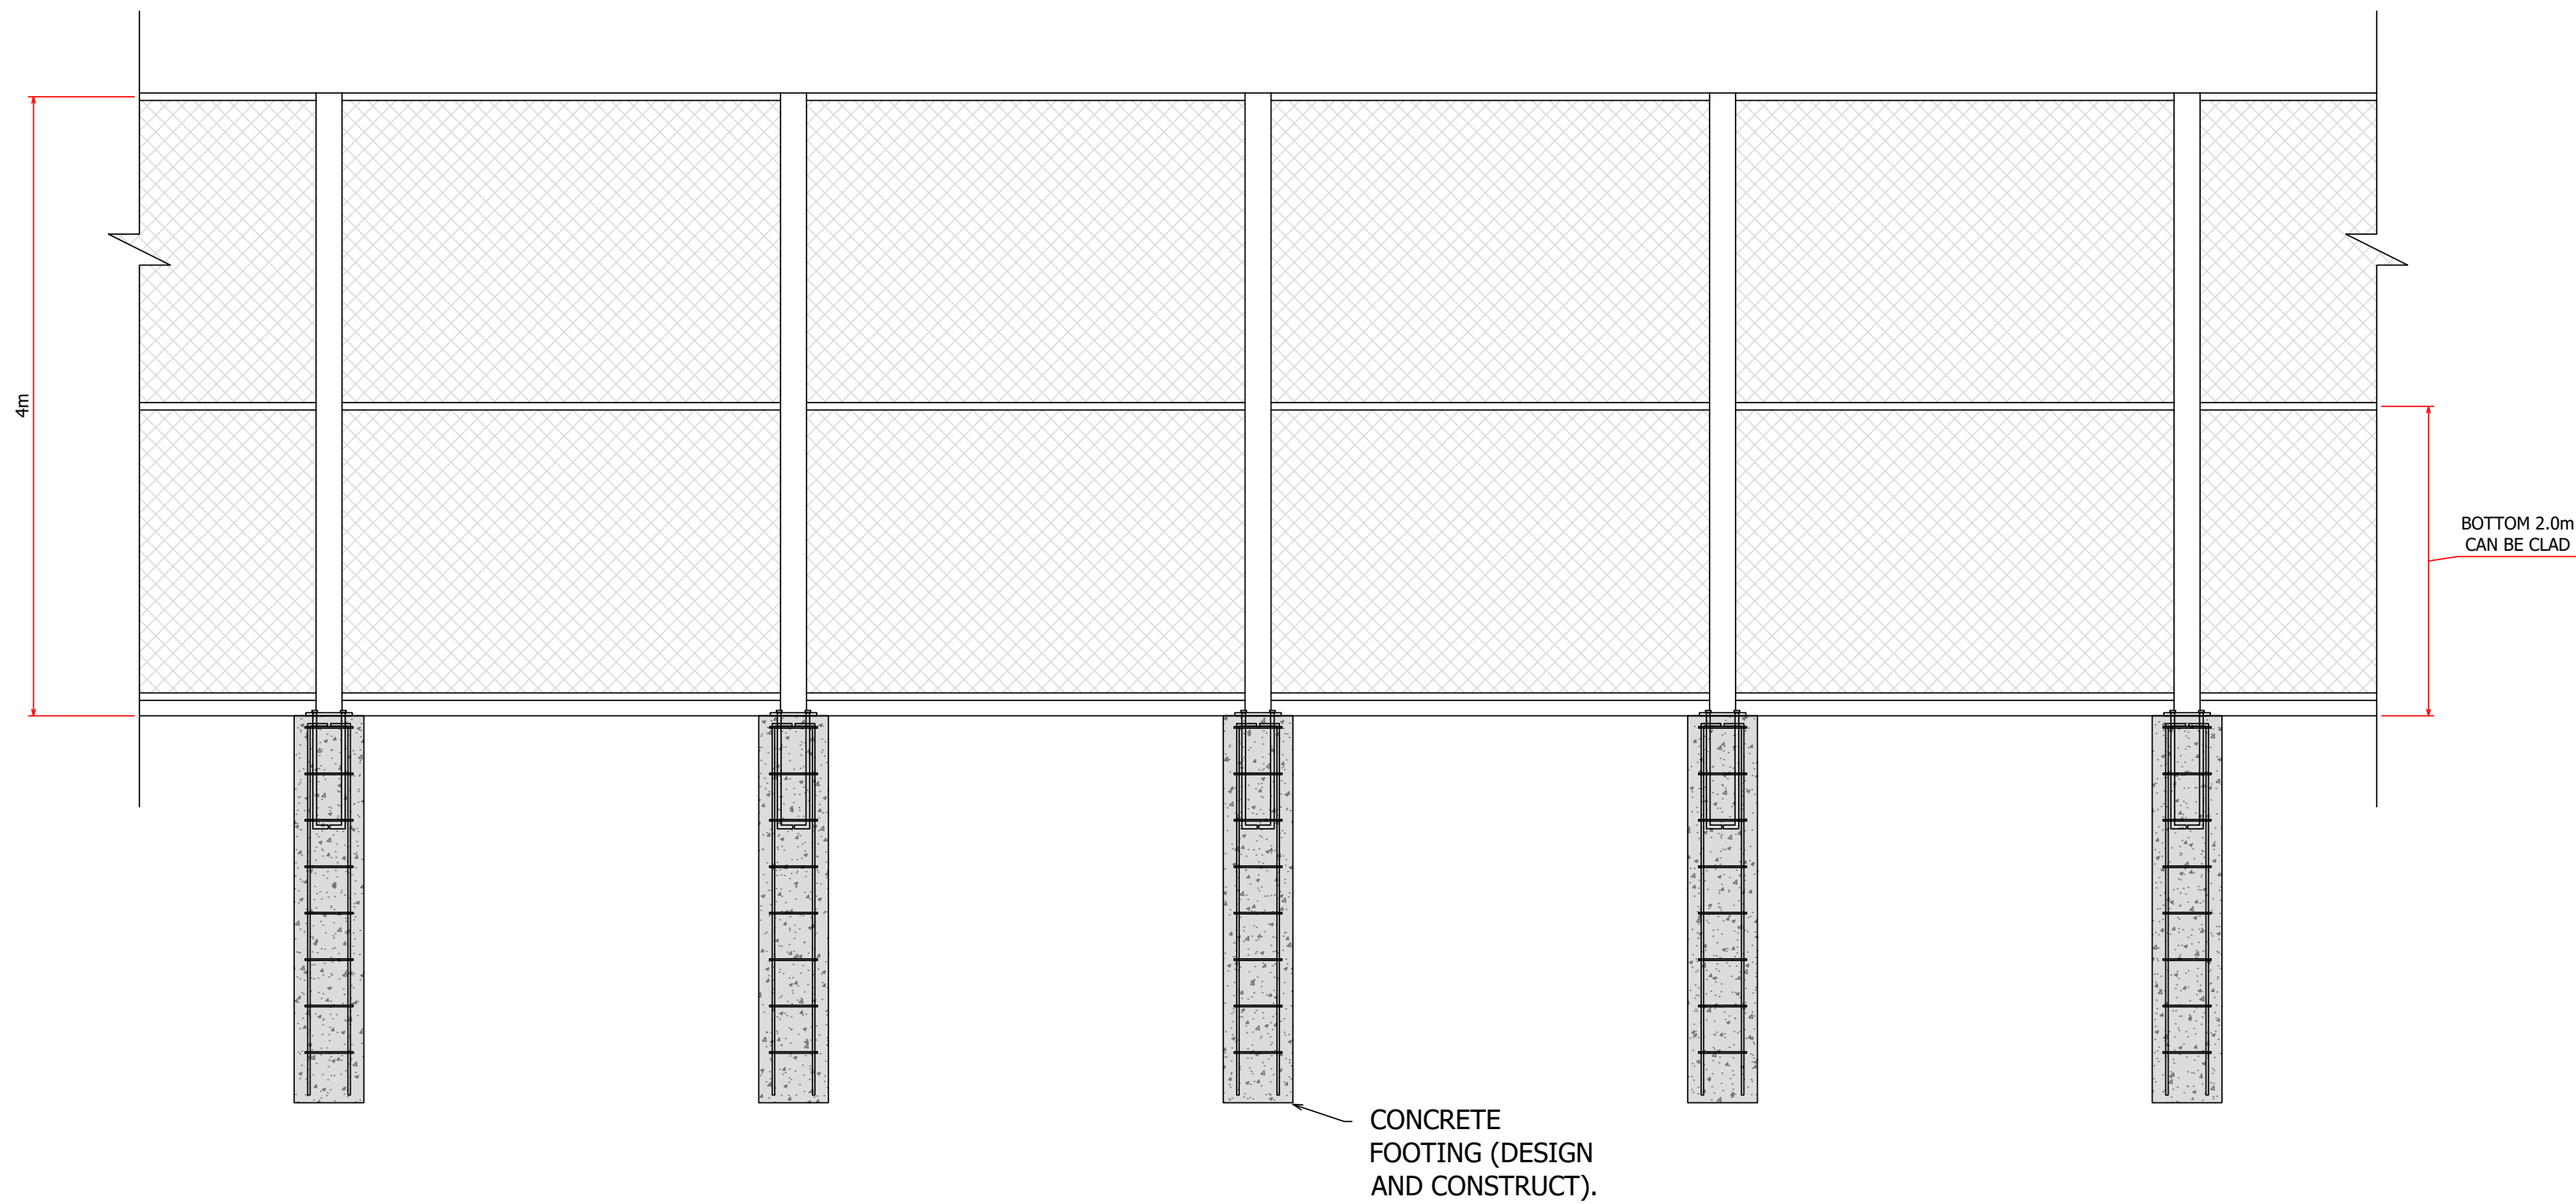

NOTE:

1. 4.0m HIGH FENCE IS DESIGN AND CONSTRUCT. REFERENCE DESIGN PROVIDED FOR DESIGN PURPOSES. FENCE SHALL BE DESIGNED AND CERTIFIED BY CHARTERED STRUCTURAL ENGINEER.

4.0m HIGH FENCE DETAIL (D&C)

NOT FOR CONSTRUCTION




P2	05/04/24	RKC	BGC	JDH	PRELIMINARY ISSUE
P1	31/01/24	RKC	BGC	JDH	PRELIMINARY ISSUE
Issue	Date	By	Chkd	Appd	Description

Job Title
RAY OWEN OVAL
REDEVELOPMENT

Drawing Title
4.0m HIGH FENCE DETAILS

Discipline	FIELD OF PLAY
Drawing Status	PRELIMINARY
Drawing Number	SE_11694_F701
Issue	P2

© SPORTENG

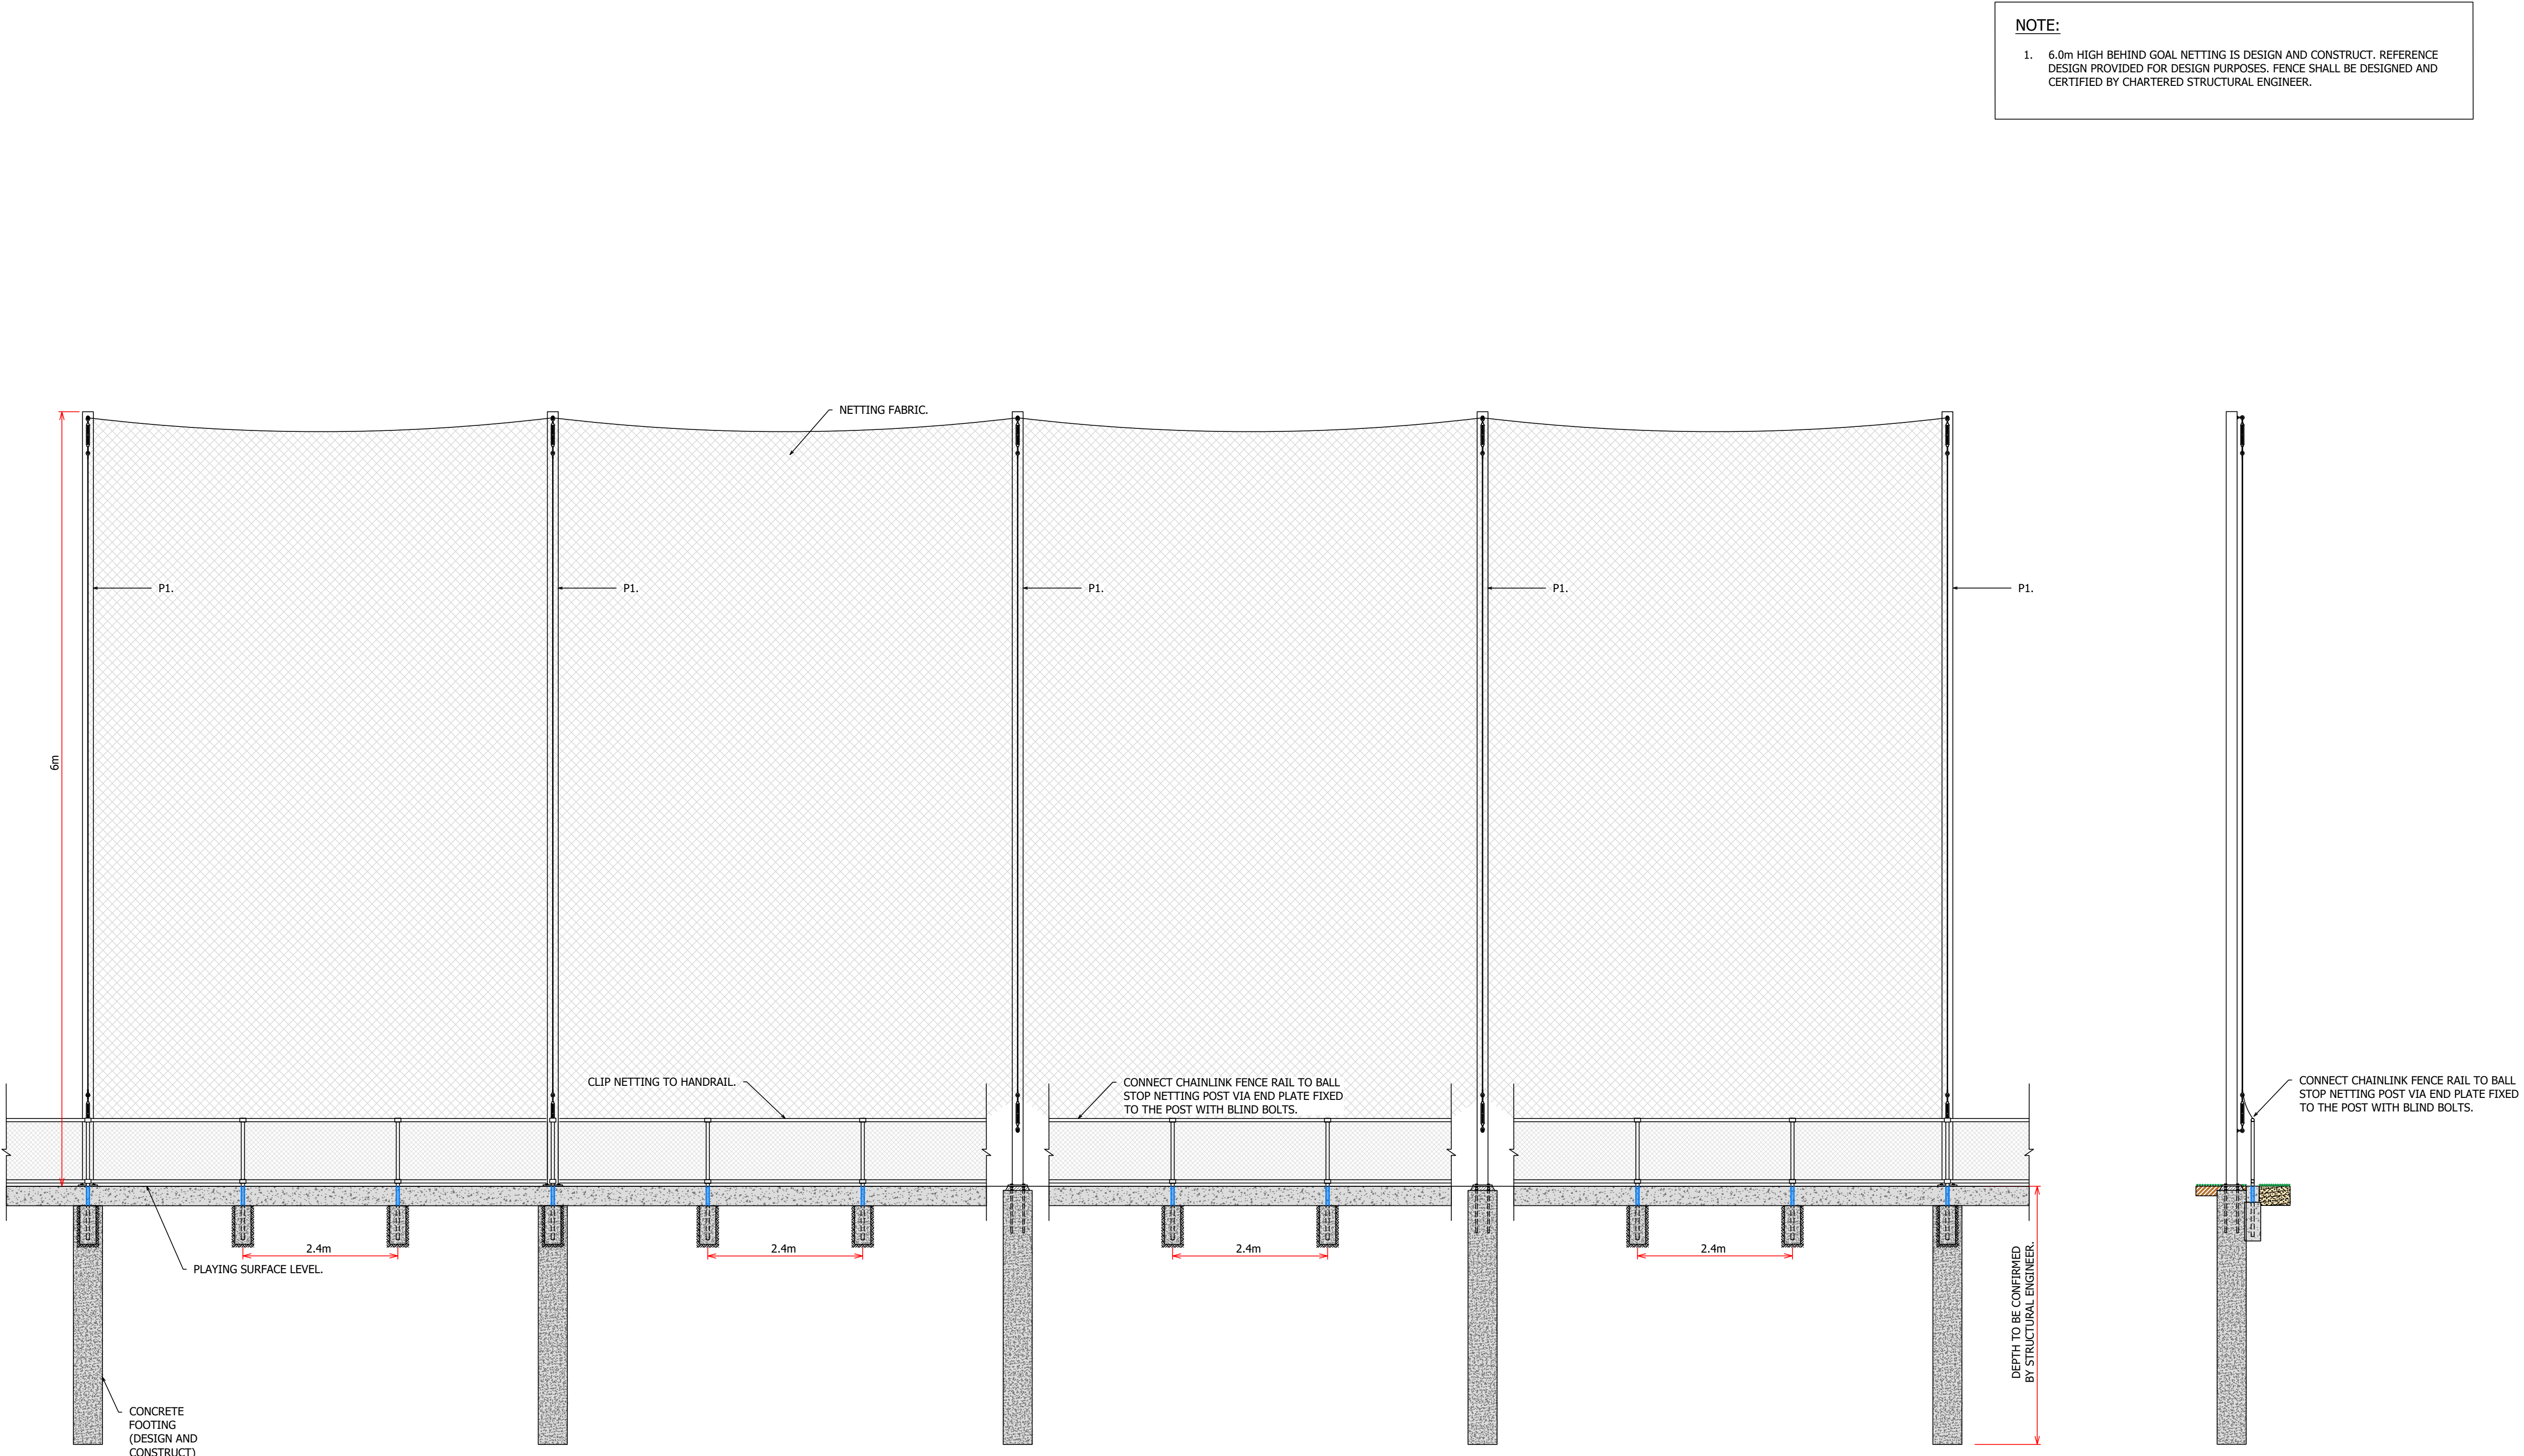

6.0m HIGH BEHIND GOAL NETTING FENCE DETAILS (D&C)

NOT FOR CONSTRUCTION



SPORTENG™

P1	05/04/24	RKC	BGC	JDH	PRELIMINARY ISSUE
Issue	Date	By	Chkd	Appd	Description

Job Title
RAY OWEN OVAL
REDEVELOPMENT

Drawing Title
6.0m HIGH BEHIND GOAL
NETTING DETAILS

Discipline
FIELD OF PLAY

Drawing Status
PRELIMINARY

Drawing Number
SE_11694_F702

Issue

P1

© SPORTENG

PLOT DATE: 05/04/2024 PLOT TIME: 4:44 PM FILE PATH: C:\1205\data\SPORTENG\11694 Ray Owen Oval Redevelopment_2217\03 Project Data\Drawings\Sheets\SE_11694_F702.dwg